


HOLTHOUSE BLDG.
TRANSVERSE BUILDING SECTION
SCALE: 1/4"=1'-0"



LEGEND:
● INDICATES EXISTING LIGHT FIXTURE
○ TO BE REPLACED

HOLTHOUSE BLDG.
EXISTING LIGHTING LAYOUT
SCALE: 1/4"=1'-0"

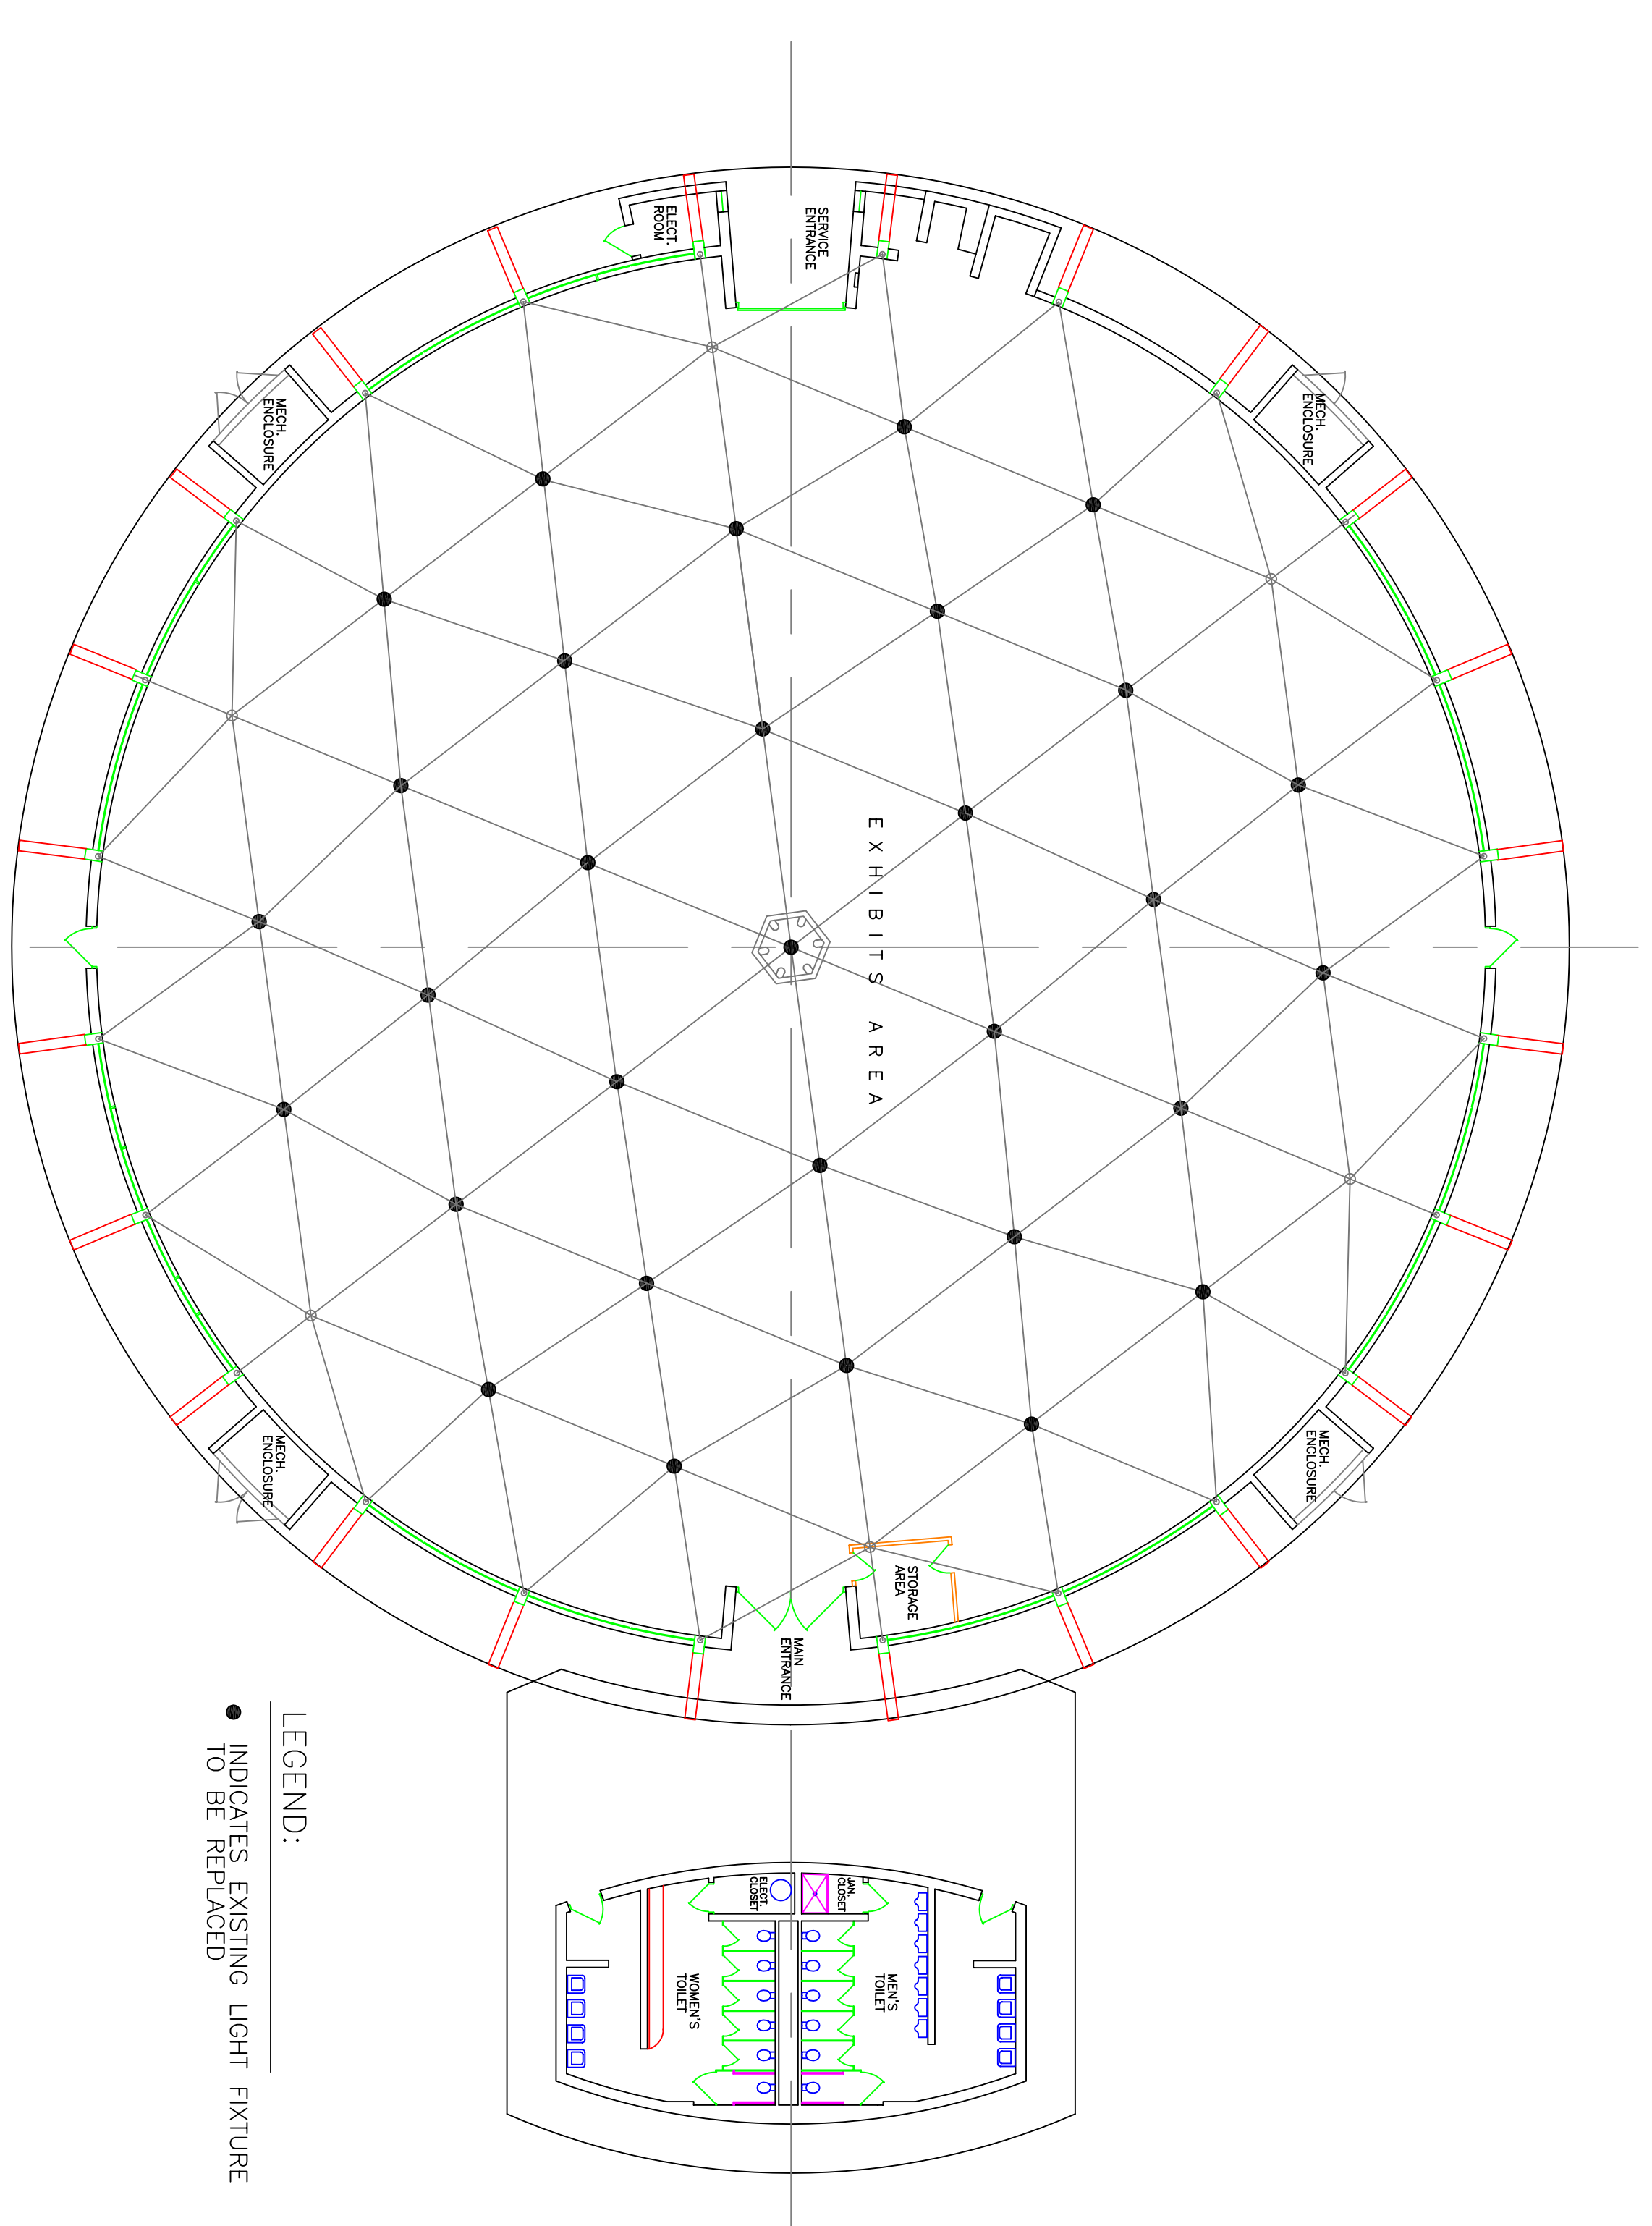